


NOMINAL DIAMETER	NOMINAL O.D.	TYPICAL SPACING "C"	TYPICAL SIDE WALL "X"	MIN. H (NON-TRAFFIC)	MIN. H (TRAFFIC)	MAX. H"
36"	42"	63"	18"	12"	12"	8'

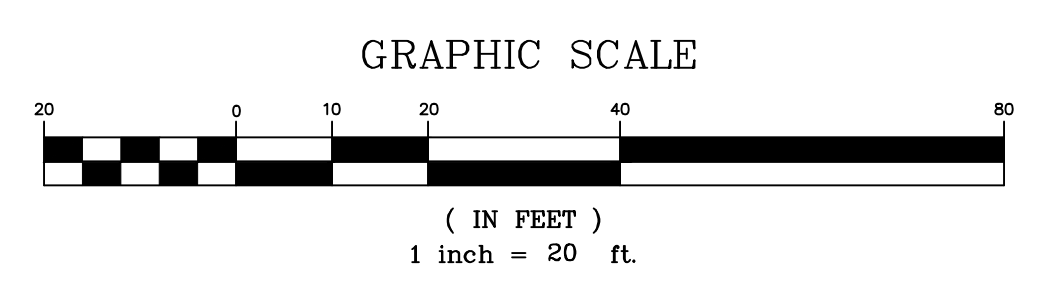

"KNOW WHAT'S BELOW"

CALL BEFORE YOU DIG
NEW JERSEY ONE CALL
DIAL 811 OR 800-272-1000
"IT IS THE LAW"

OMICK, INC. MECHANICAL & ELECTRICAL ENGINEERS
T: (201) 444-0303 F: (201) 444-0339
ALAN ALON, PE, STRUCTURAL ENGINEER
T: (908) 752-8500 F: (908) 752-8507
ONE ASSOCIATES, CONSULTING AND MUNICIPAL ENGINEERS
849 9TH ST., 2ND FLOOR, NEW BRUNSWICK, NJ 08901
LUDWIG CONSULTING ENGINEERS, TECHNOLOGY CONSULTANTS
LUDWIG CONSULTING ENGINEERS, TECHNOLOGY CONSULTANTS
T: (609) 798-6800 F: (609) 798-6802

GREGORY R. VALES, PE, PP
N.J. LICENSE #A240344800

THE GOLDSTEIN PARTNERSHIP ARCHITECTS
515 VALLEY STREET, SUITE 110, MAPLEWOOD, NJ 07040
OFFICE: 973-261-4550
COPYRIGHT ©2019 BY THE GOLDSTEIN PARTNERSHIP. ALL RIGHTS RESERVED.

BARNEGAT MUNICIPAL BUILDING
900 WEST BAY AVENUE
BARNEGAT, NJ 08005

GRADING AND DRAINAGE PLAN (1 OF 2)
SCALE: AS NOTED
DATE: 05/01/20
DWN: ZJ
CND: KGO

THIS DRAWING IS INCOMPLETE UNLESS USED WITH ALL OTHER CONTRACT DOCUMENTS.

DRAWING NUMBER
C-9
SHEET 85 OF 97